


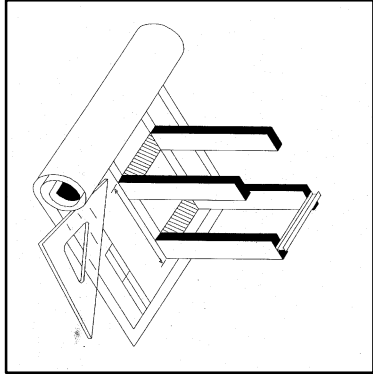

Marcelli Design & Construction

5159 Western Avenue
Altamont, New York 12009


Tel: (518) 253-8408
Fax: (518) 356-2230

Revision No.	Description	Date
	ADDED NOTES	11-27-23
	6 DETAILS FOR	
	FLUO-C HEATING	

Project No.	0000
Drawing Date:	11-13-23
Issue Date:	11-13-23
Scale:	AS NOTED
Drawn By:	DPM
Checked By:	MPB


2 ACCESSIBLE RAMP SECTION • REAR OF PROPOSED ADDITION

SK3 SCALE 1/4" = 1'-0"

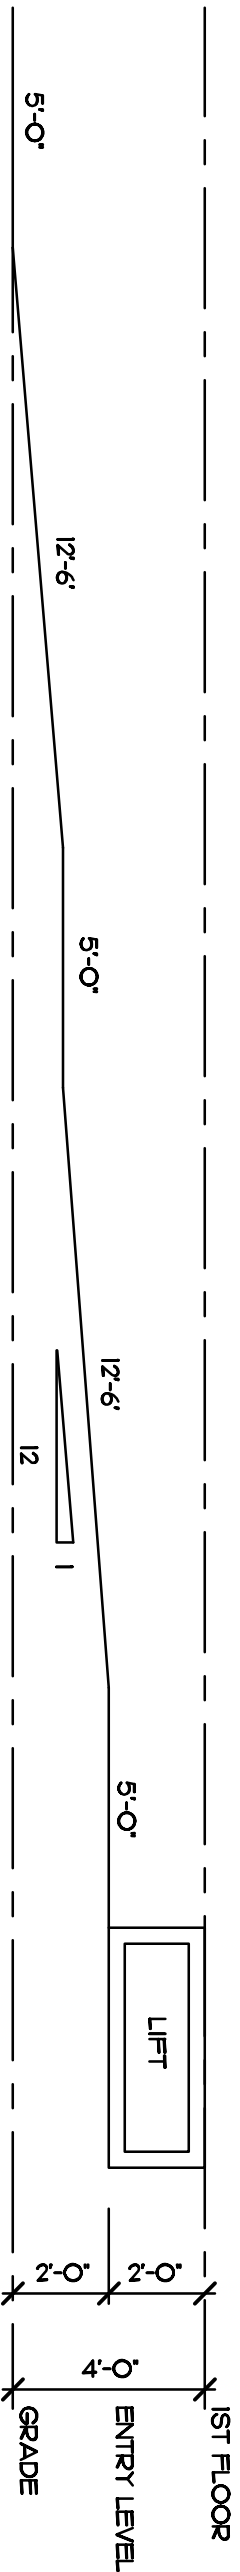

1 PROPOSED EXTERIOR ELEVATION • FRONT

SK3 SCALE 1/4" = 1'-0"

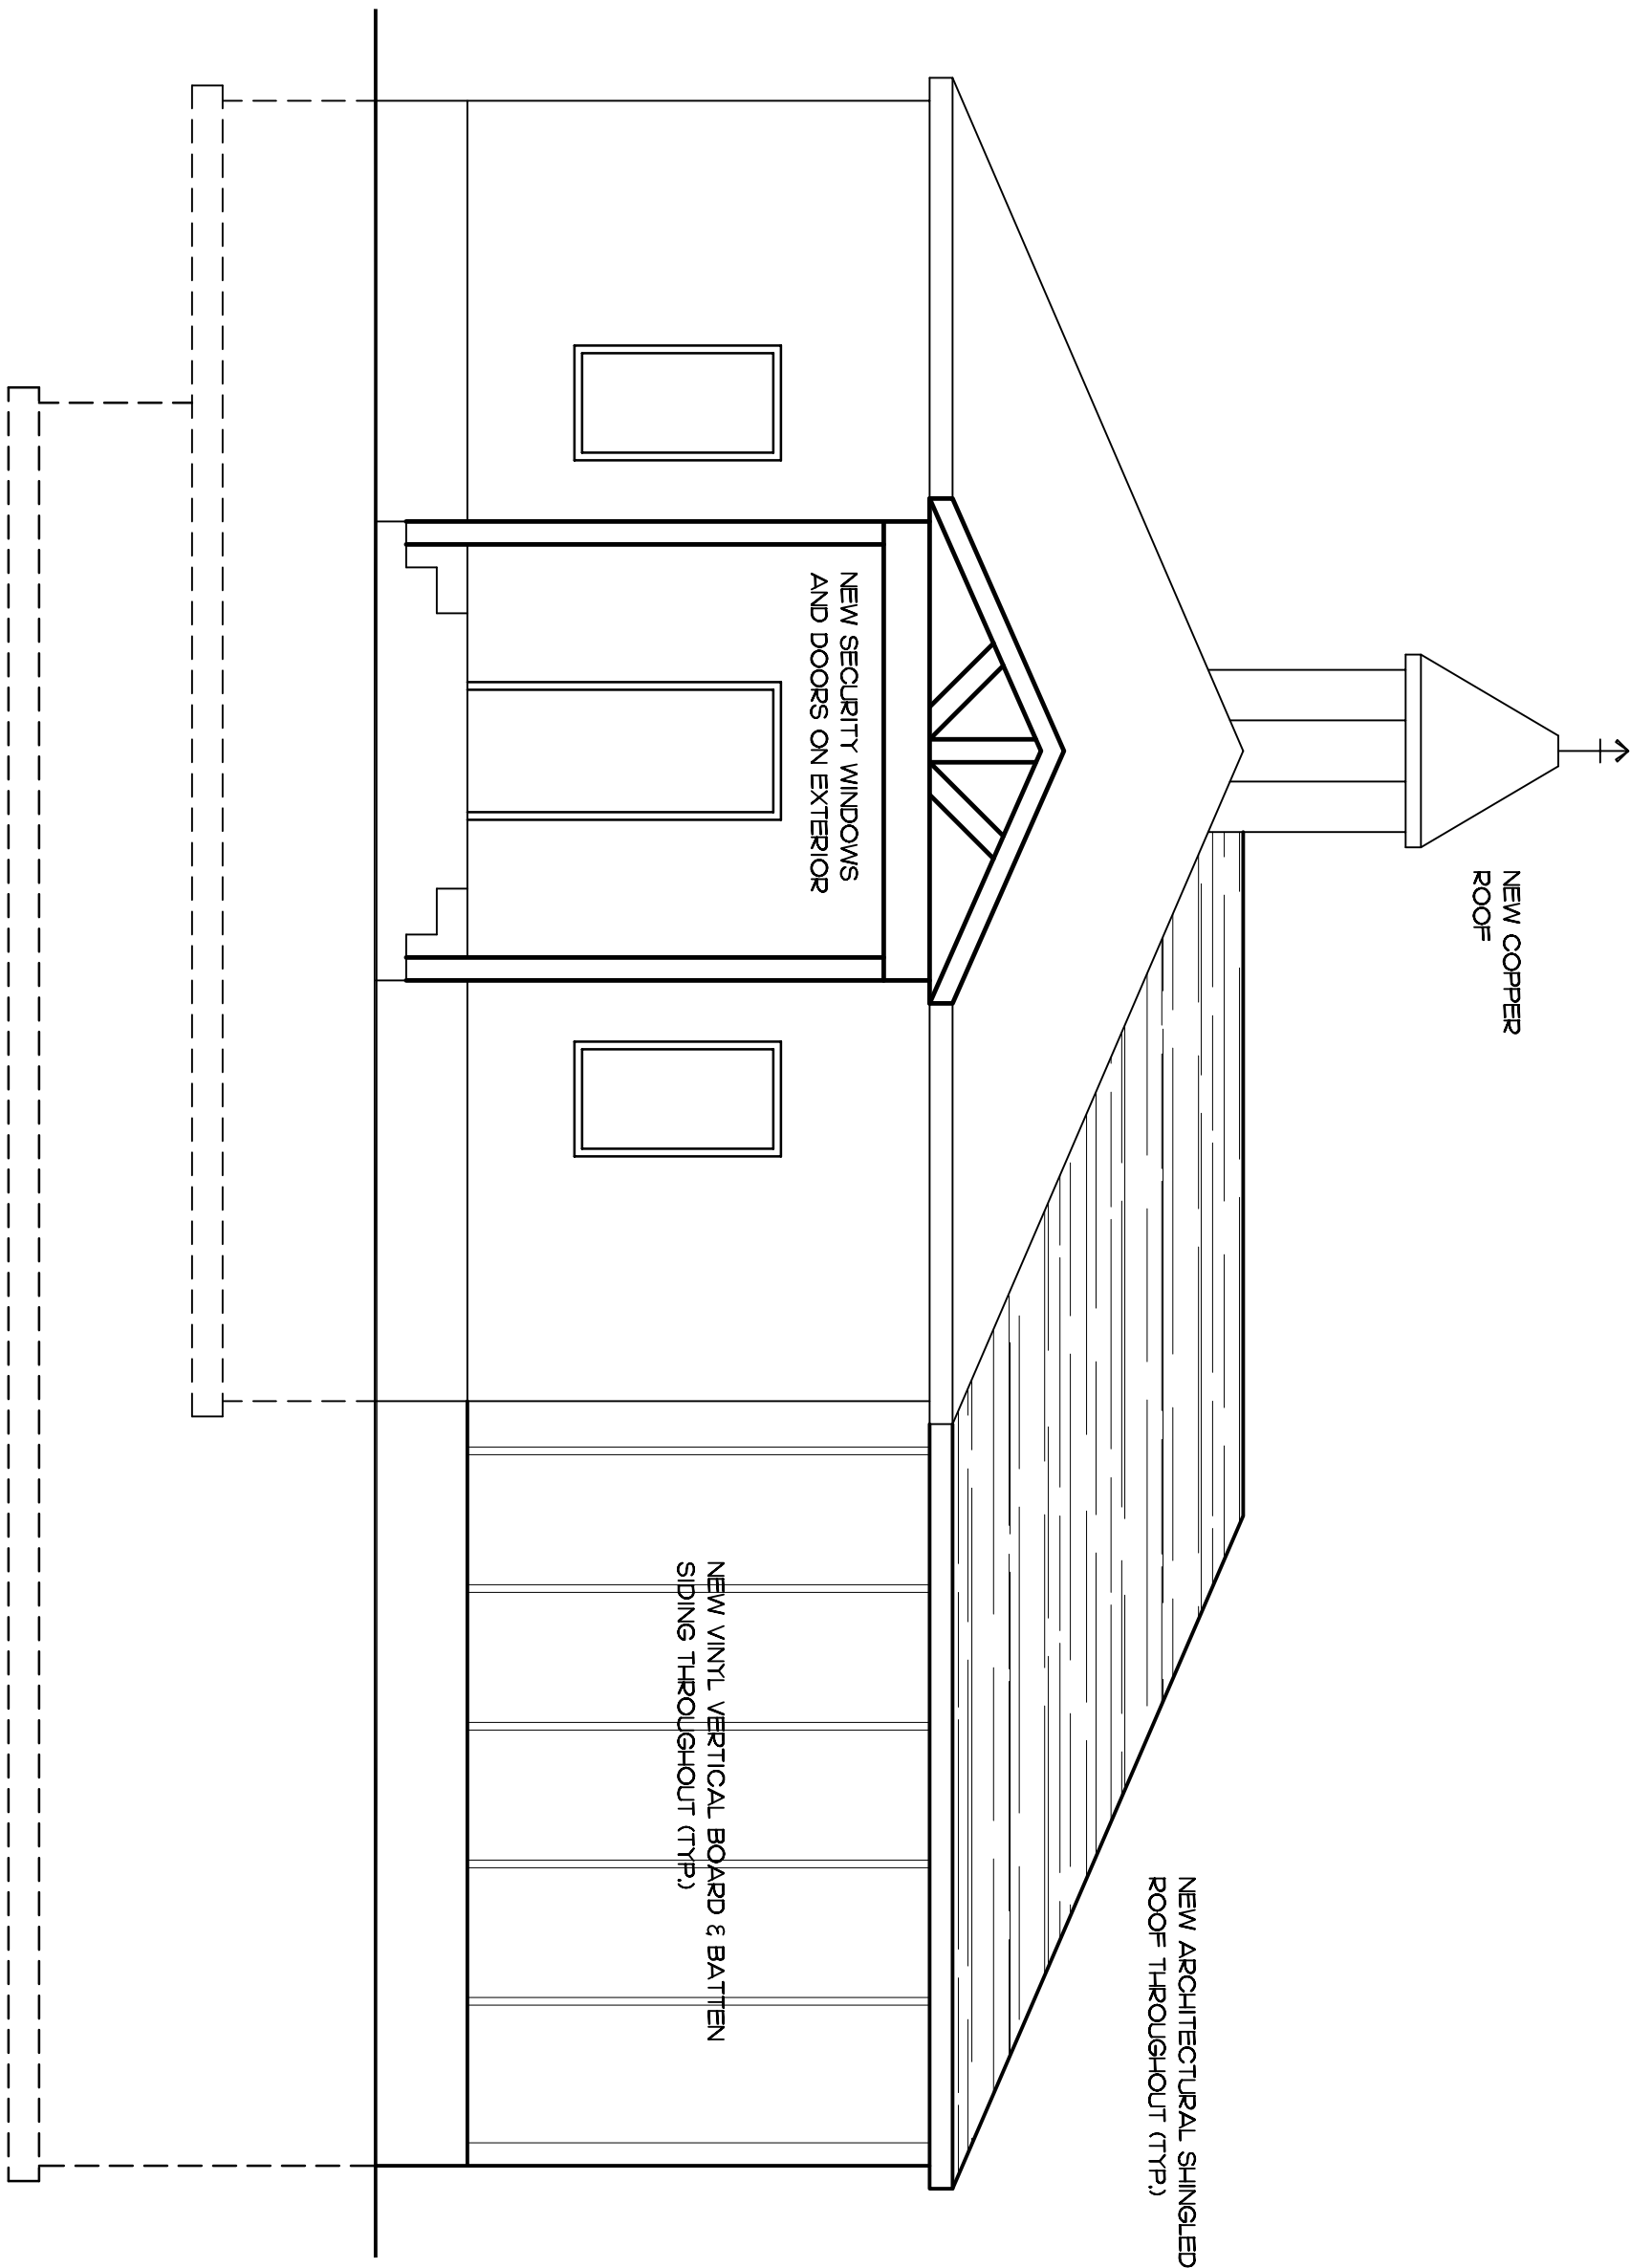

PROPOSED BLOOM CANNABIS DISPENSARY
716 BLOOMINGROVE DRIVE
TOWN OF NORTH GREENBUSH, NEW YORK

PROPOSED EXTERIOR BUILDING ELEVATIONS

X

SK3

4 of 4